


# PLAN VIEW

SCALE: 1/32"=1'0"

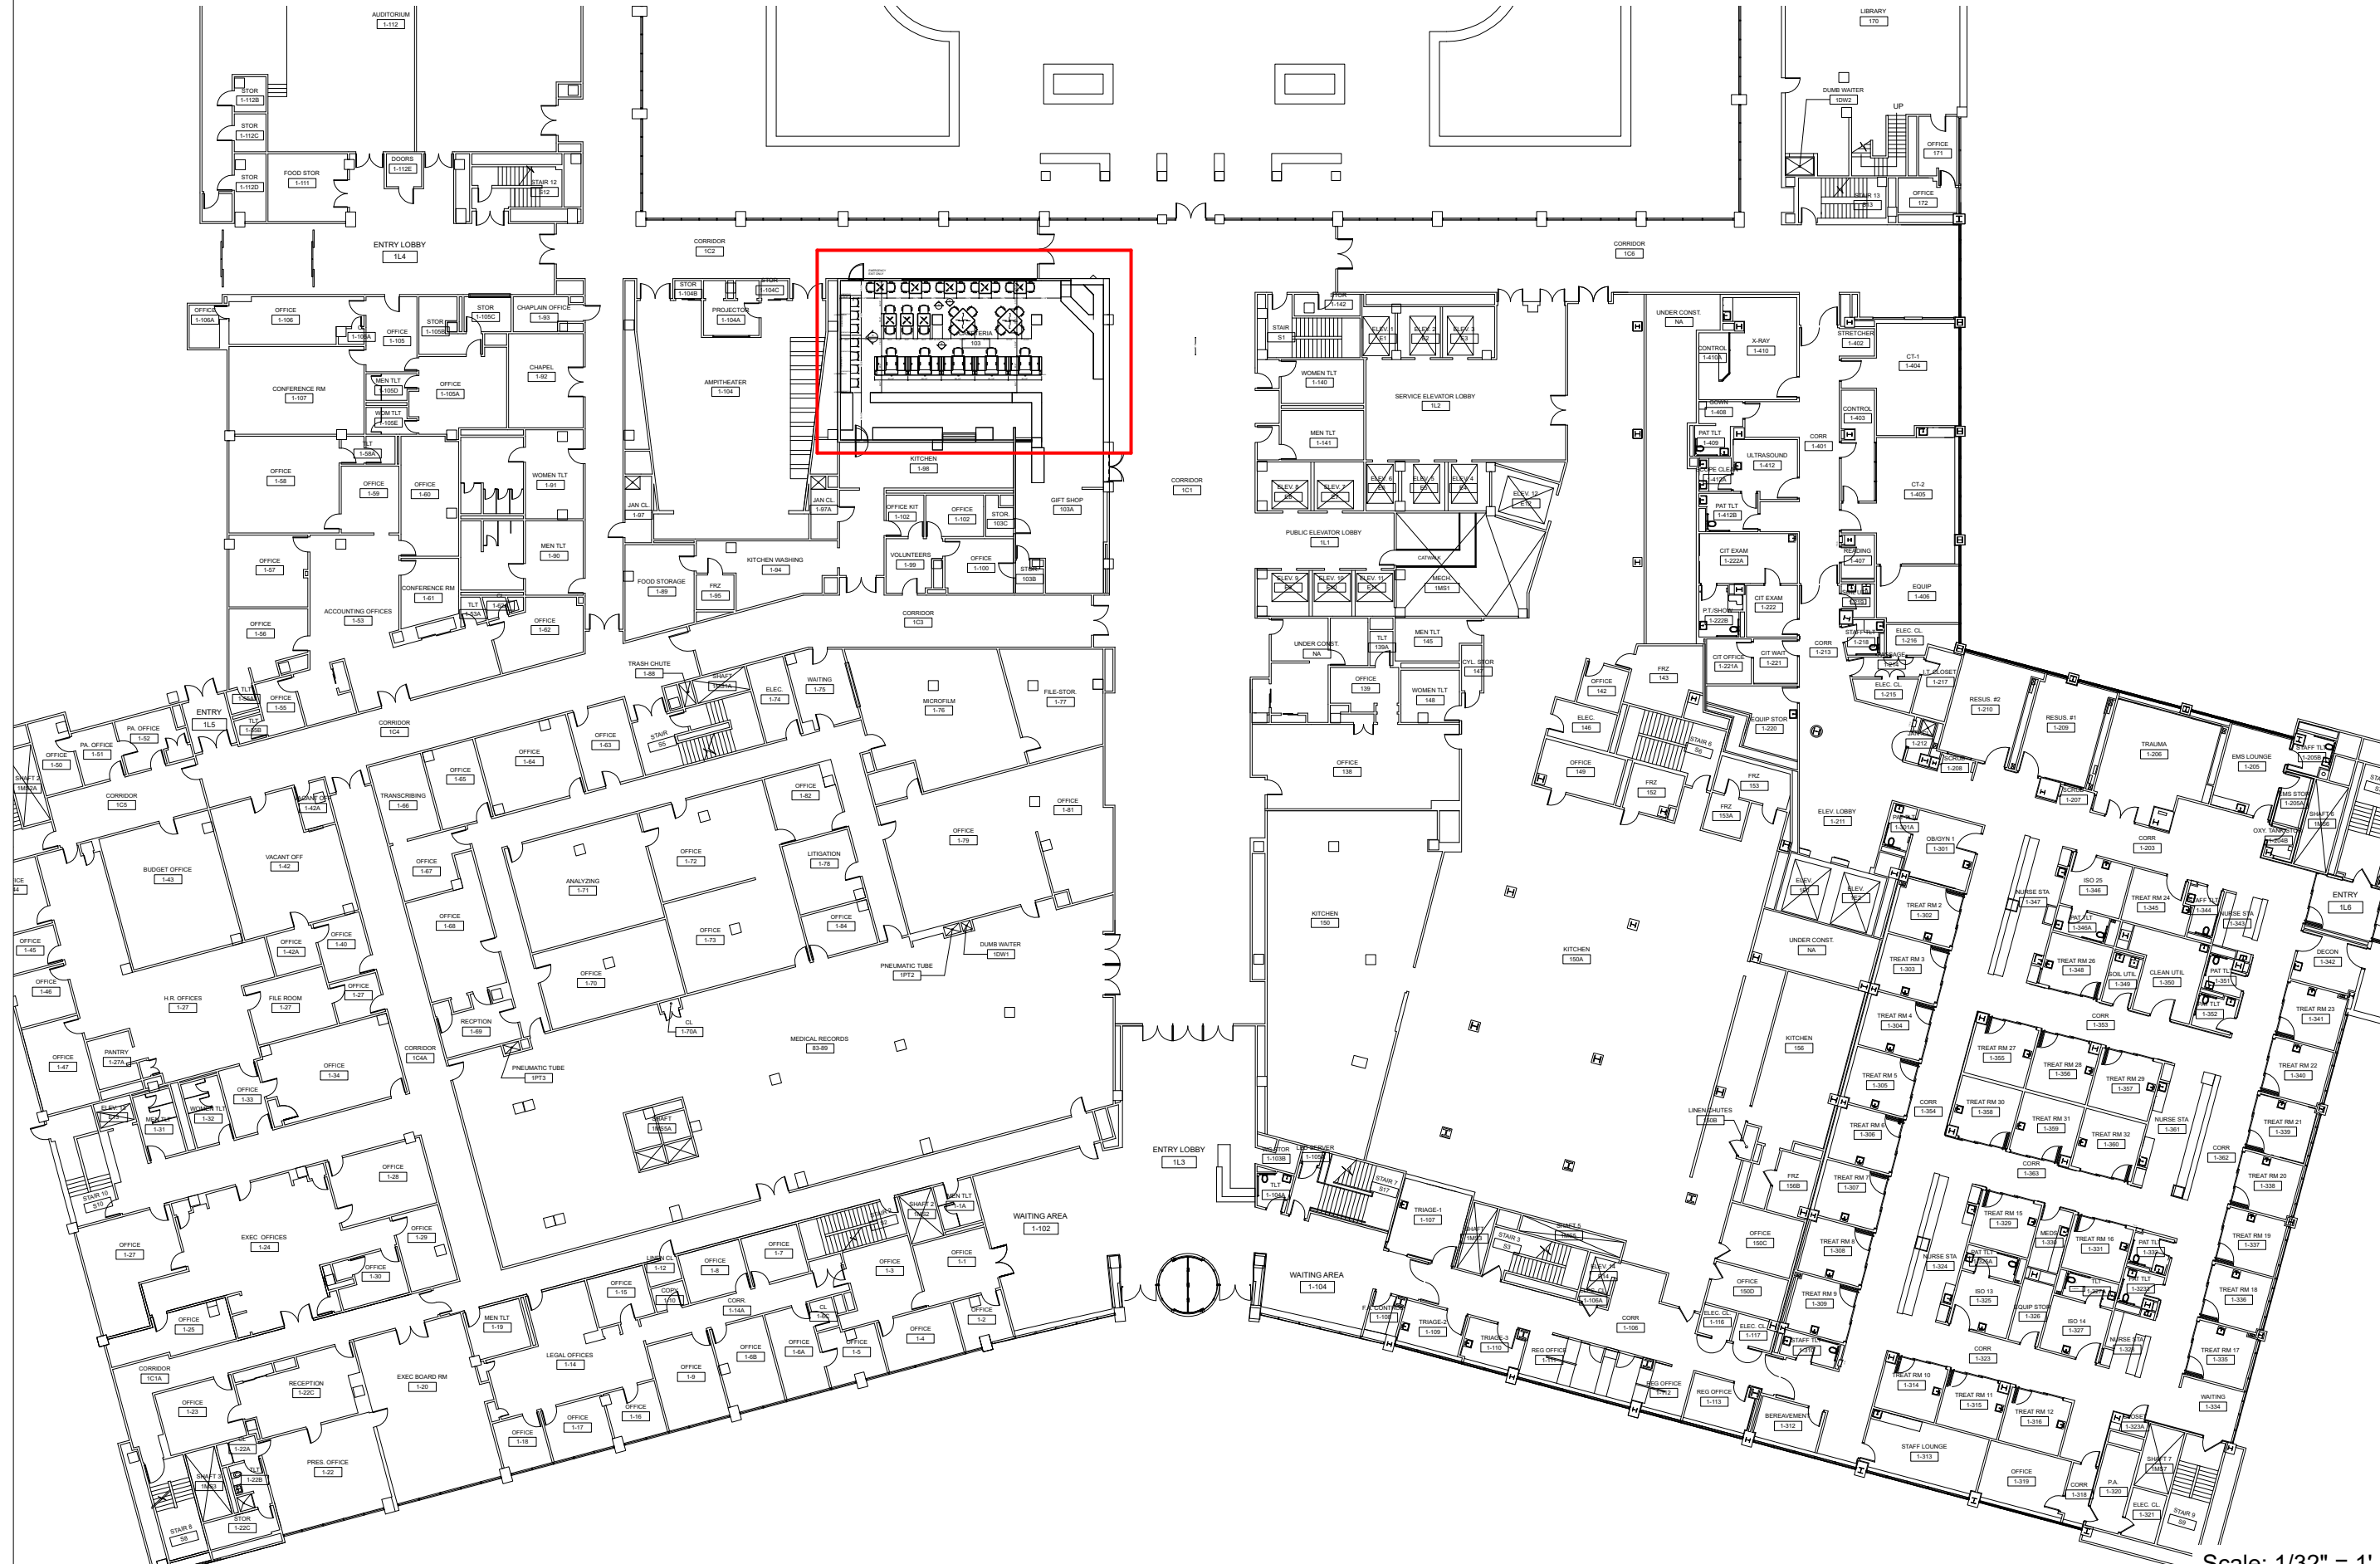

Scale: 1/32" = 1'

(NOT FOR ARCHITECTURAL PURPOSES)

HEADQUARTERS  
New York, NY  
105 Madison Avenue  
New York, NY 10016  
212.607.5500

Hollywood, FL  
2 Oakwood Blvd  
Suite 140  
Hollywood, FL 33020  
954.707.6200  
Lic No: IB26001451

Orlando, FL  
110 Hillcrest St  
Orlando, FL 32801  
407.628.2400  
Lic No: IB26001451

Tampa, FL  
5112 W. Linebaugh Ave  
Tampa, FL 33624  
813.418.3300  
Lic No: IB26001451

**empire office**

www.empireoffice.com

DWN BY:	G-G
CHK BY:	Dml
DATE:	23.05.2019
SCALE:	1/32"=1'-0"
PRJ FNO:	000000
APPROVED BY:	

NY 11554


**NUMC**  
Coffee Shop Renovation  
STEELCASE  
2201 Hempstead Turnpike

EMPIRE OFFICE SHALL NOT BE HELD LIABLE FOR ANY ERRORS, OMISSIONS OR DISCREPANCIES THAT MAY OCCUR FROM THE USE OF THESE PLANS. FIELD VERIFICATION REQUIRED BY OTHERS FOR ACCURACY. THESE ARE NOT AND SHALL NOT BE USED FOR PERMIT AND/OR CONSTRUCTION PURPOSES. THESE ELECTRICAL PLANS ARE FOR FURNITURE REFERENCE ONLY AND SHALL NOT BE COPIED OR DISTRIBUTED WITHOUT A WRITTEN AUTHORIZATION FROM EMPIRE OFFICE. ALL ELECTRICAL INFORMATION IS PROVIDED AS A COURTESY AND IS THE CLIENT'S AND/OR THE CLIENT'S REPRESENTATIVE'S (INCLUDING BUT NOT LIMITED TO GENERAL CONTRACTOR AND/OR ARCHITECT) RESPONSIBILITY TO FIELD VERIFY ALL DIMENSIONS / INFORMATION FOR ACCURACY. EMPIRE OFFICE SHALL BE HELD HARMLESS OF ANY ERRORS, OMISSIONS OR DISCREPANCIES.

# PLAN VIEW

SCALE: 1/4"=1'0"

EMERGENCY  
EXIT ONLY

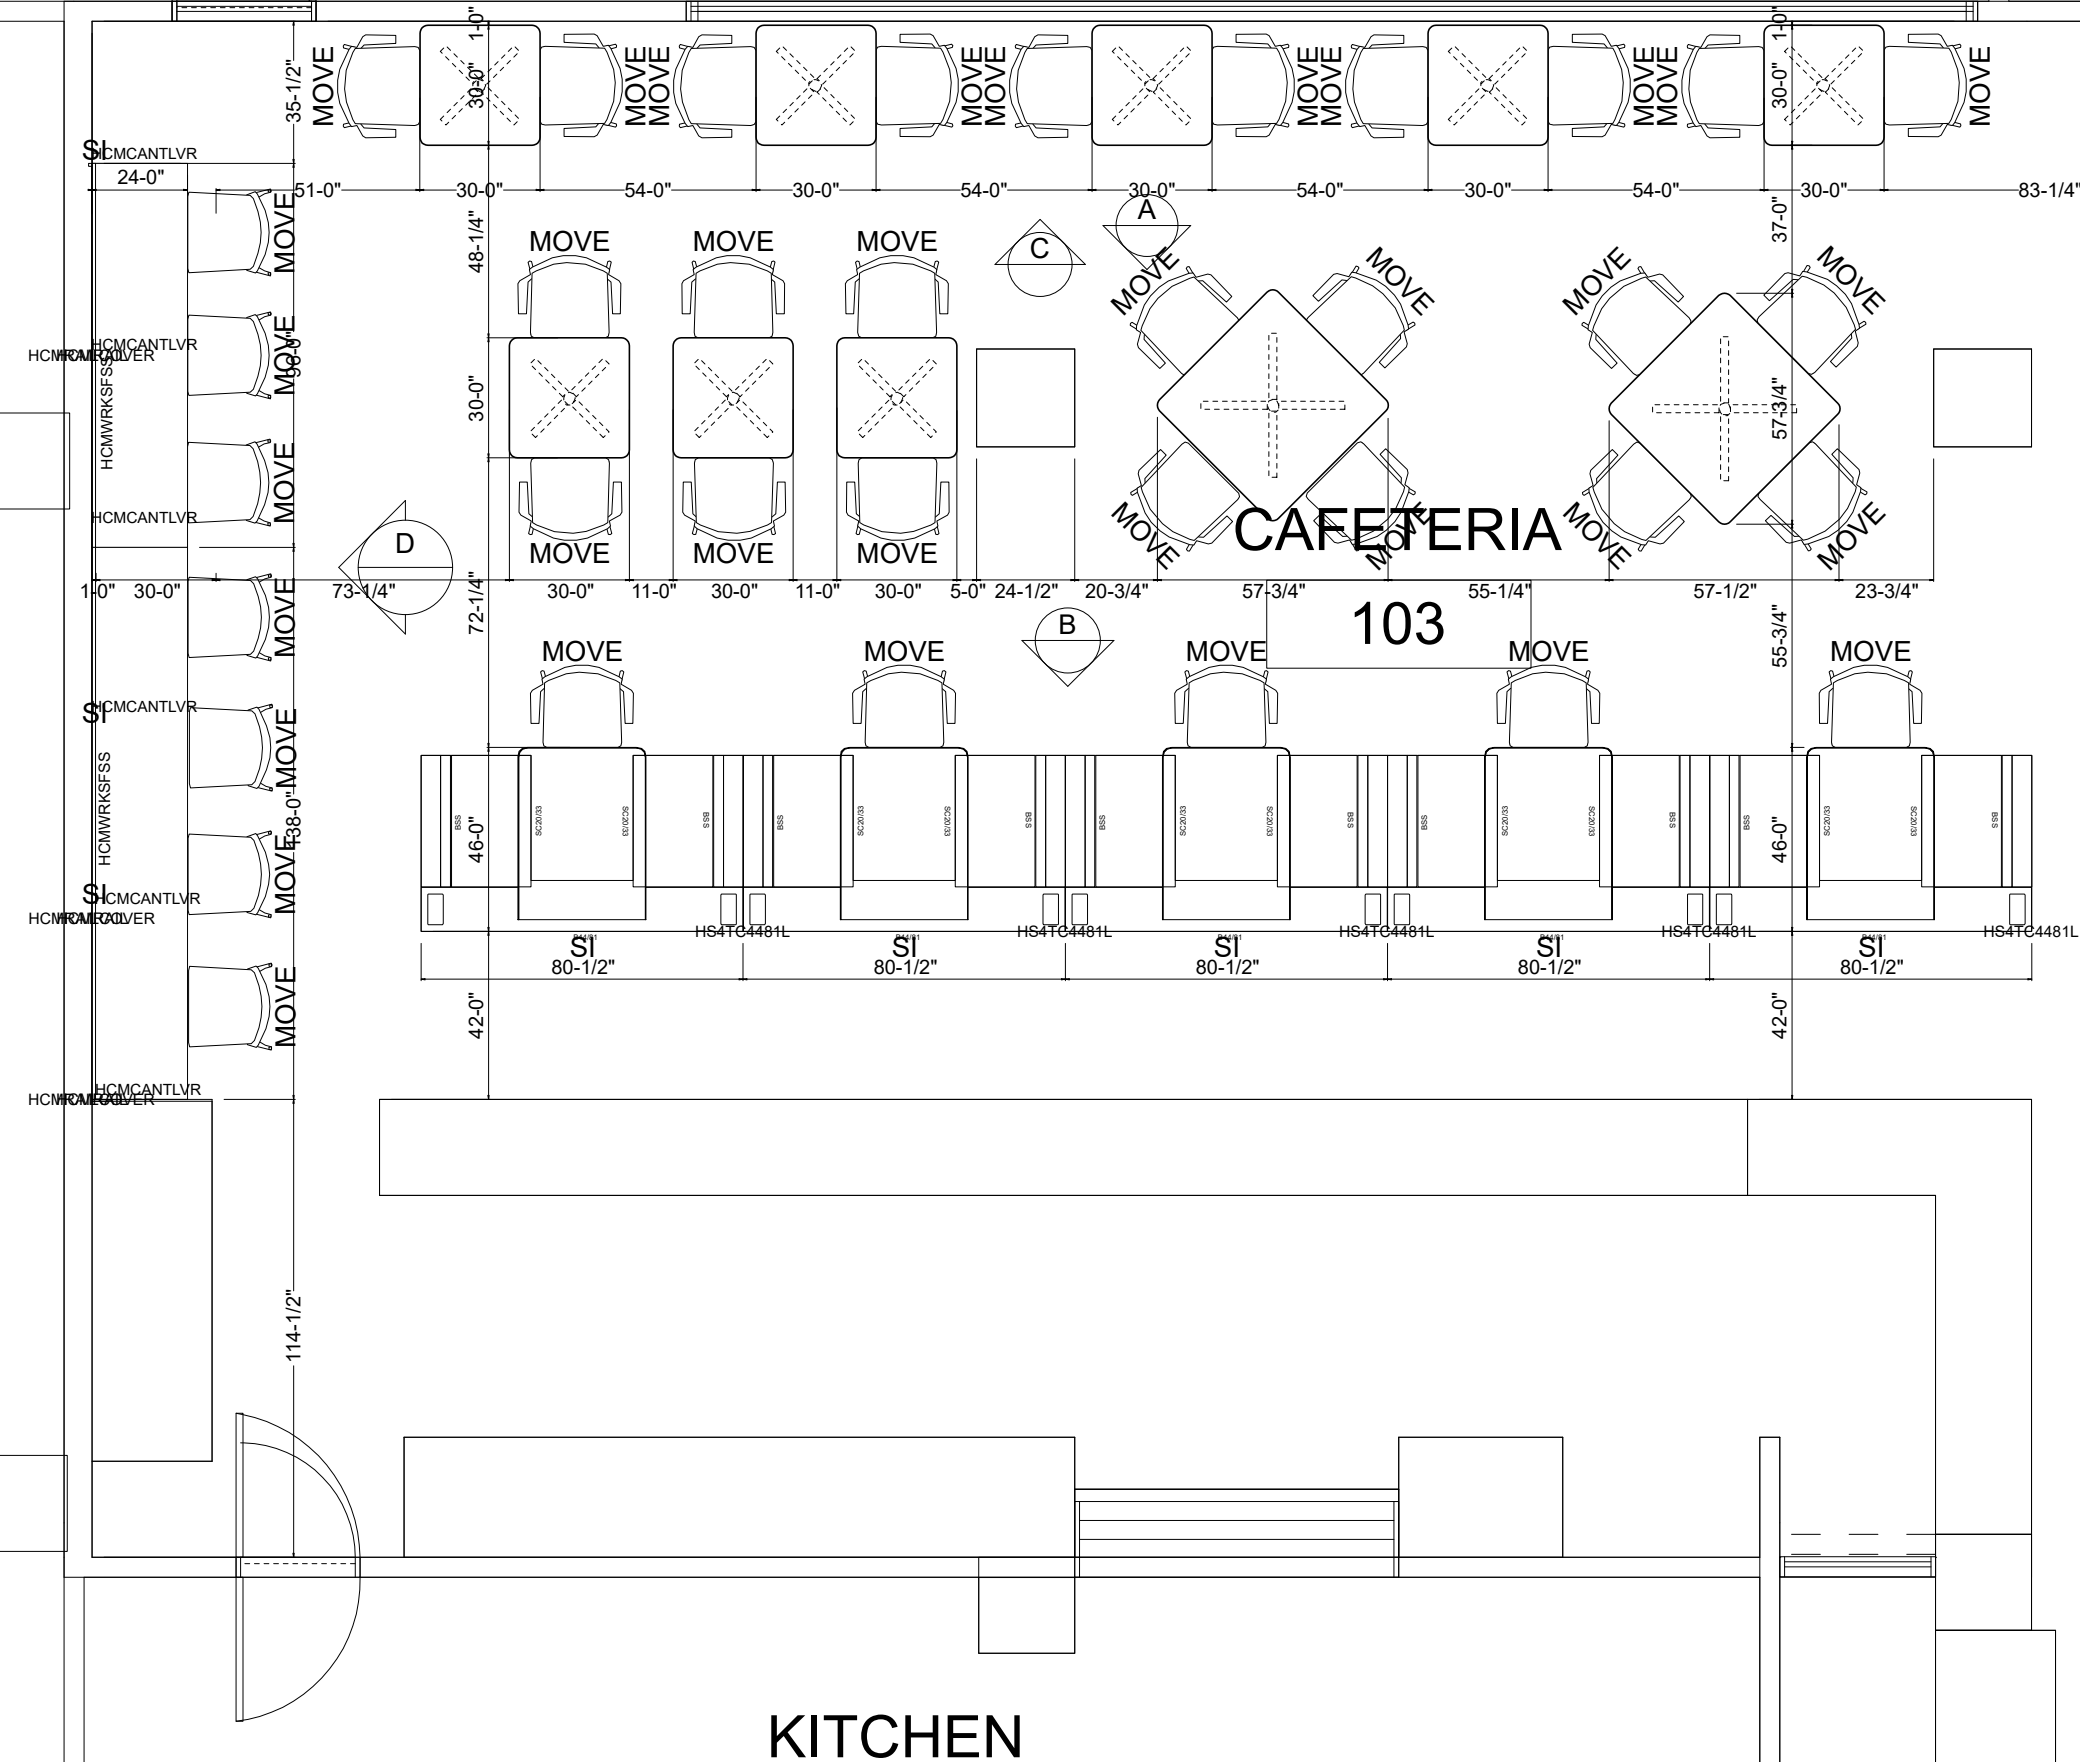

Scale: 1/4" = 1'

EMPIRE OFFICE SHALL NOT BE HELD LIABLE FOR ANY ERRORS, OMISSIONS OR DISCREPANCIES THAT MAY OCCUR FROM THE USE OF THESE PLANS. FIELD VERIFICATION REQUIRED BY OTHERS FOR ACCURACY. THESE ARE NOT AND SHALL NOT BE USED FOR PERMIT AND/OR CONSTRUCTION PURPOSES. THESE ELECTRICAL PLANS ARE FOR FURNITURE REFERENCE ONLY AND SHALL NOT BE COPIED OR DISTRIBUTED WITHOUT A WRITTEN AUTHORIZATION FROM EMPIRE OFFICE. ALL ELECTRICAL INFORMATION IS PROVIDED AS A COURTESY AND IT IS THE CLIENT'S AND/OR THE CLIENT'S REPRESENTATIVES' (INCLUDING BUT NOT LIMITED TO GENERAL CONTRACTOR AND/OR ARCHITECT) RESPONSIBILITY TO FIELD VERIFY ALL DIMENSIONS / INFORMATION FOR ACCURACY. EMPIRE OFFICE SHALL BE HELD HARMLESS OF ANY ERRORS, OMISSIONS OR DISCREPANCIES.

(NOT FOR ARCHITECTURAL PURPOSES)

HEADQUARTERS  
New York, NY  
105 Madison Avenue  
New York, NY 10016  
212.607.5500

Hollywood, FL  
2 Oakwood Blvd  
Suite 140  
Hollywood, FL 33020  
954.707.6200  
Lic No: IB26001451

Orlando, FL  
110 Hillcrest St  
Orlando, FL 32801  
407.628.2400  
Lic No: IB26001451

Tampa, FL  
5112 W. Linebaugh Ave  
Tampa, FL 33624  
813.418.3300  
Lic No: IB26001451


**empire office**

www.empireoffice.com


DWN BY:	GG	
CHK BY:	Dell	
DATE:	23.05.2019	
SCALE:	1/4"=1'0"	
PRJ NO:	000000	
APPROVED BY:		
REV	DWR	DATE

**NUMC**  
Coffee Shop Renovation  
STEELCASE  
2201 Hempstead Turnpike  
NY 11554


# ELEVATIONS

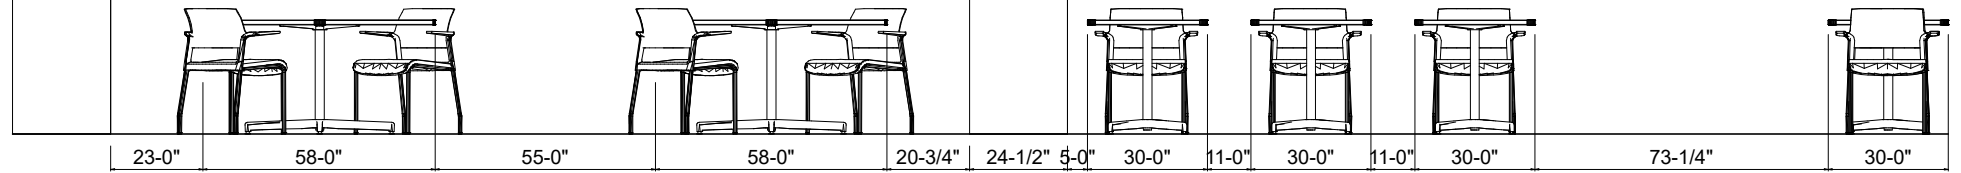

## Elevation A

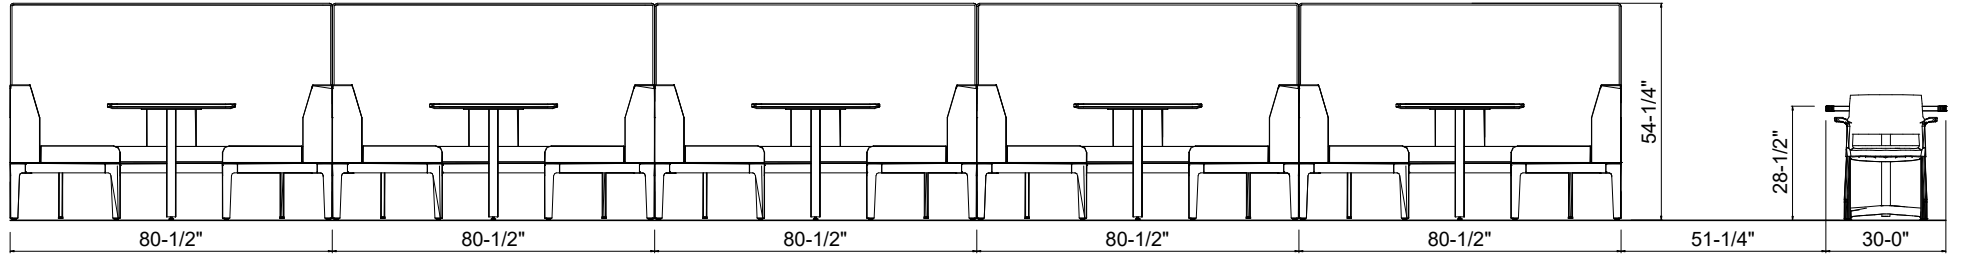

## Elevation B

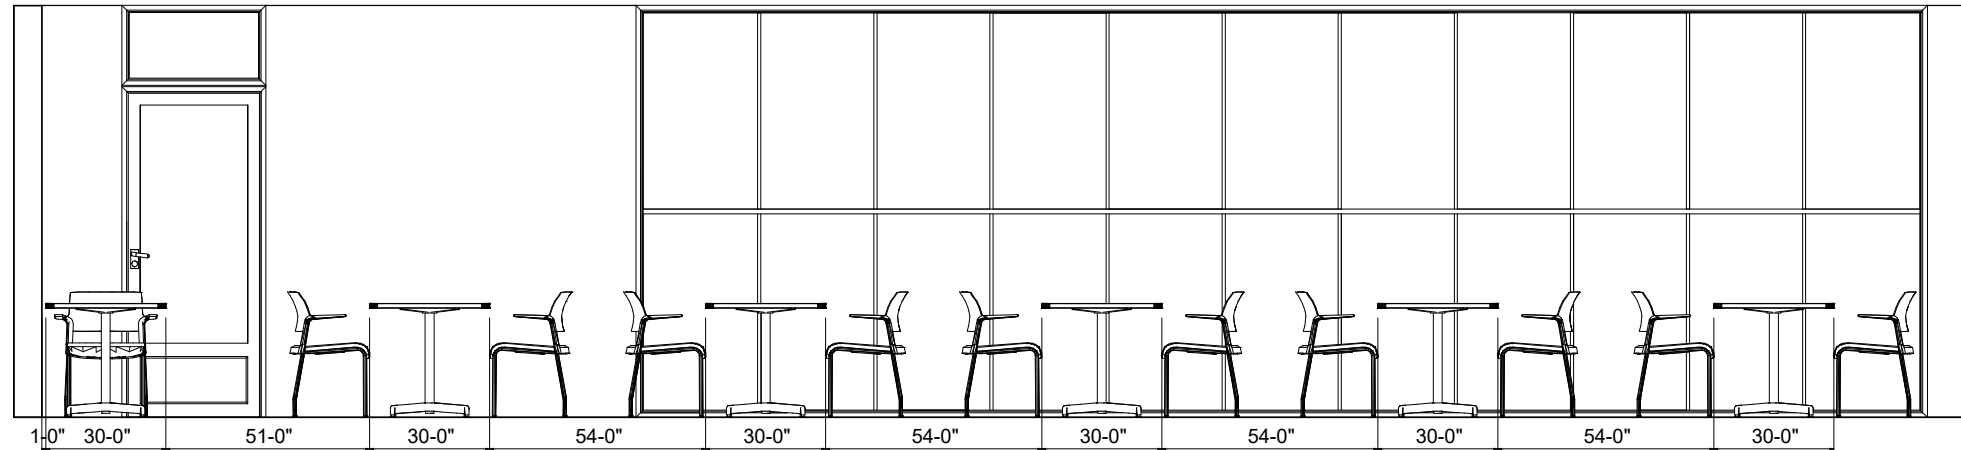

## Elevation C

Scale: 1/4" = 1'

EMPIRE OFFICE SHALL NOT BE HELD LIABLE FOR ANY ERRORS, OMISSIONS OR DISCREPANCIES THAT MAY OCCUR FROM THE USE OF THESE PLANS. FIELD VERIFICATION REQUIRED BY OTHERS FOR ACCURACY. THESE ARE NOT AND SHALL NOT BE USED FOR PERMIT AND/OR CONSTRUCTION PURPOSES. THESE ELECTRICAL PLANS ARE FOR FURNITURE REFERENCE ONLY AND SHALL NOT BE COPIED OR DISTRIBUTED WITHOUT A WRITTEN AUTHORIZATION FROM EMPIRE OFFICE.

ALL ELECTRICAL INFORMATION IS PROVIDED AS A COURTESY AND IT IS THE CLIENTS AND/OR THE CLIENTS REPRESENTATIVES (INCLUDING BUT NOT LIMITED TO GENERAL CONTRACTOR AND/OR ARCHITECT) RESPONSIBILITY TO FIELD VERIFY ALL DIMENSIONS / INFORMATION FOR ACCURACY. EMPIRE OFFICE SHALL BE HELD HAMRLESS OF ANY ERRORS, OMISSIONS OR DISCREPANCIES.

(NOT FOR ARCHITECTURAL PURPOSES)

PAGE NO.: 3/6

**NUMC**  
Coffee Shop Renovation  
**STEELCASE**

2201 Hempstead Turnpike

NY 11554

DWN BY: GG	REV	DWN	DATE
CHK BY: Dell			
DATE: 23.05.2019			
SCALE: 1/4"=1'-0"			
PRJT NO: 000000			
APPROVED BY:			

www.empireoffice.com

**empire office**

**Tampa, FL**  
5112 W. Linebaugh Ave  
Tampa, FL 33624  
813.418.3300  
Lic No: IB26001451

**Orlando, FL**  
110 Hillcrest St  
Orlando, FL 32801  
407.626.2400  
Lic No: IB26001451

**Hollywood, FL**  
2 Oakwood Blvd  
Suite 140  
Hollywood, FL 33020  
954.707.6200  
Lic No: IB26001451

**HEADQUARTERS**  
New York, NY  
105 Madison Avenue  
New York, NY 10016  
212.697.5500

# ISOMETRIC VIEW



EMPIRE OFFICE SHALL NOT BE HELD LIABLE FOR ANY ERRORS, OMISSIONS OR DISCREPANCIES THAT MAY OCCUR FROM THE USE OF THESE PLANS. FIELD VERIFICATION REQUIRED BY OTHERS FOR ACCURACY. THESE ARE NOT AND SHALL NOT BE USED FOR PERMIT AND/OR CONSTRUCTION PURPOSES. THESE ELECTRICAL PLANS ARE FOR FURNITURE REFERENCE ONLY AND SHALL NOT BE COPIED OR DISTRIBUTED WITHOUT A WRITTEN AUTHORIZATION FROM EMPIRE OFFICE.

ALL ELECTRICAL INFORMATION IS PROVIDED AS A COURTESY AND IT IS THE CLIENTS AND/OR THE CLIENTS REPRESENTATIVES (INCLUDING BUT NOT LIMITED TO GENERAL CONTRACTOR AND/OR ARCHITECT) RESPONSIBILITY TO FIELD VERIFY ALL DIMENSIONS / INFORMATION FOR ACCURACY. EMPIRE OFFICE SHALL BE HELD HAMRLESS OF ANY ERRORS, OMISSIONS OR DISCREPANCIES.

(NOT FOR ARCHITECTURAL PURPOSES)

PAGE NO.: 4/6

## NUMC Coffee Shop Renovation STEELCASE

2201 Hempstead Turnpike

NY 11554

REV	DWN	DATE
DWN BY:	GG	
CHK BY:	Dell	
DATE:	23.05.2019	
SCALE:	-	
PRJ# NO:	000000	
APPROVED BY:		

www.empireoffice.com

**empire office**


Tampa, FL  
5112 W. Linebaugh Ave  
Tampa, FL 33624  
813.418.3300  
Lic No.: IB26001451

Orlando, FL  
110 Hillcrest St  
Orlando, FL 32801  
407.628.2400  
Lic No.: IB26001451

Hollywood, FL  
2 Oakwood Blvd  
Suite 140  
Hollywood, FL 33020  
954.707.6200  
Lic No.: IB26001451

HEADQUARTERS  
New York, NY  
105 Madison Avenue  
New York, NY 10016  
212.697.5500

# ISOMETRIC VIEW

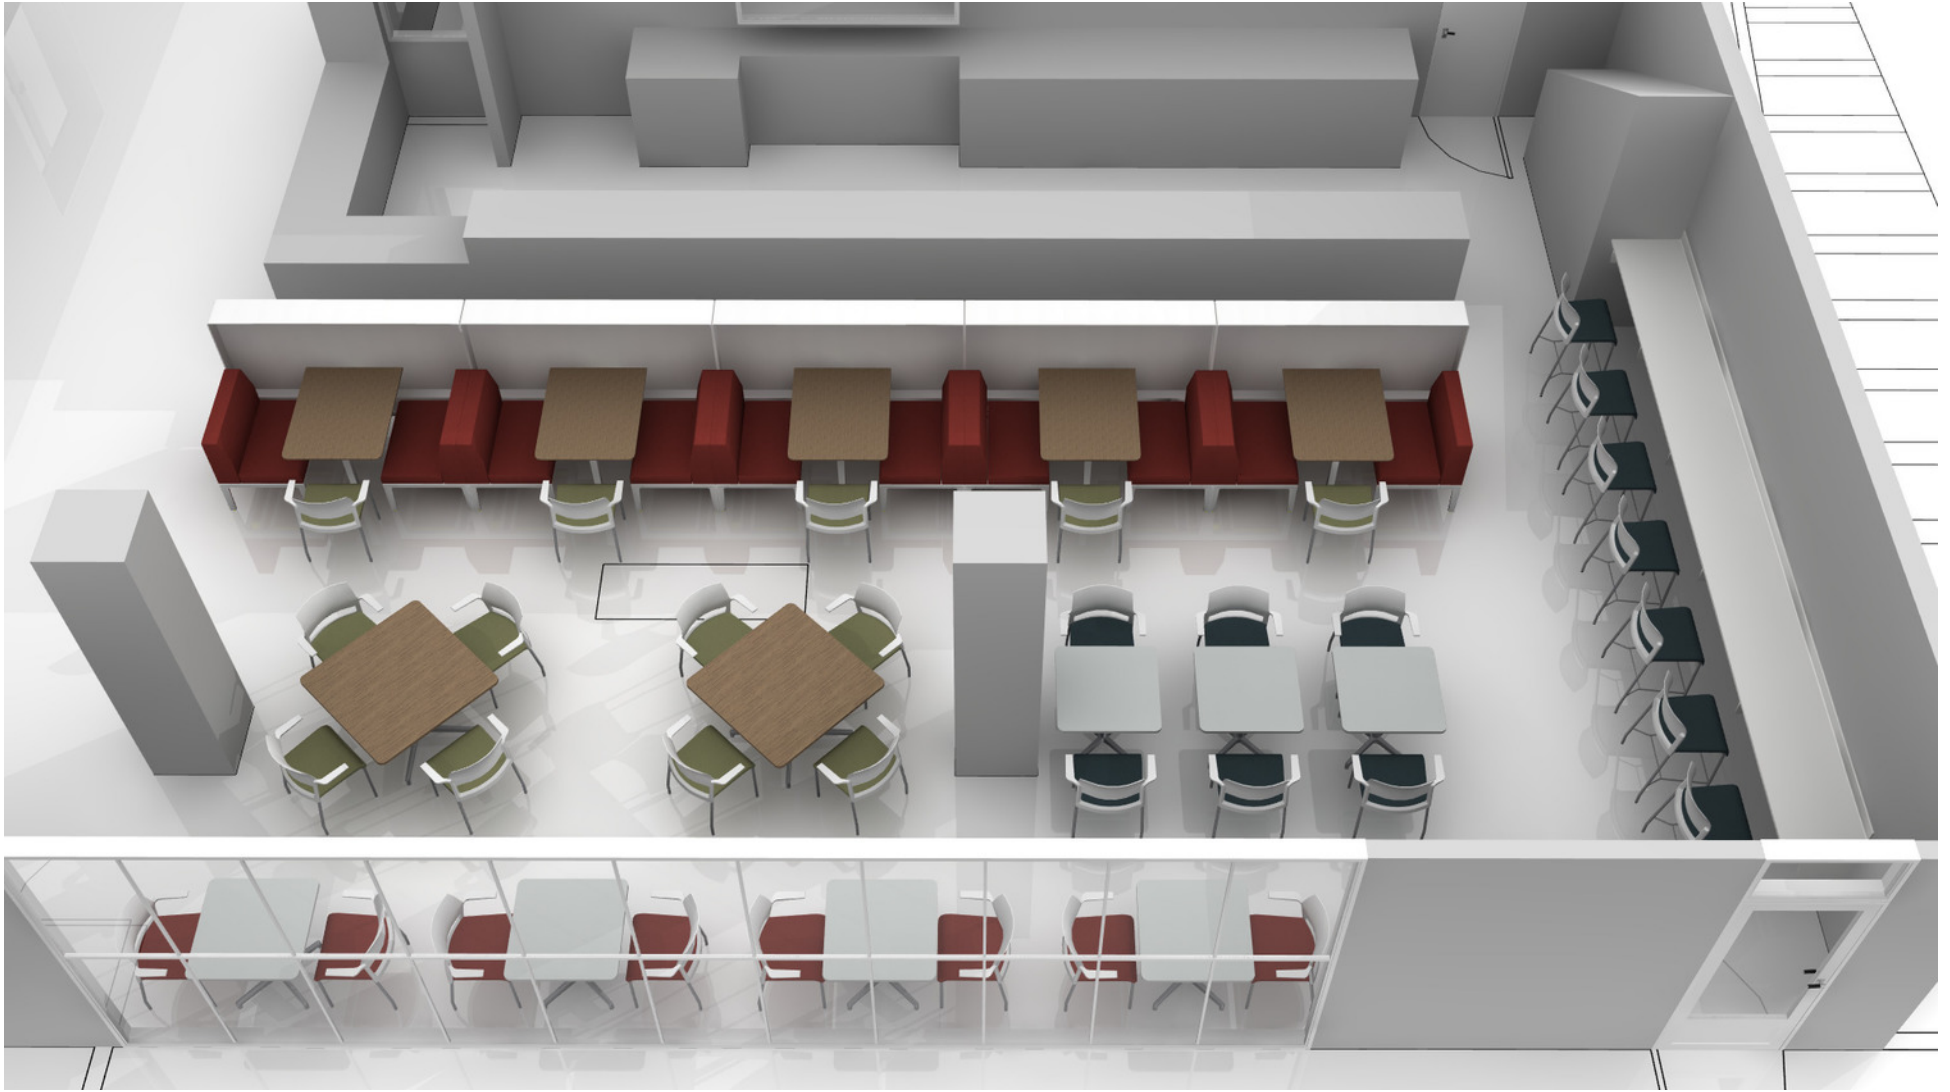

Empire Office, Inc. 110 Hillcrest St., Orlando, FL 32801  
 407.525.2400  
 Lic. No.: IB26001451

EMPIRE OFFICE SHALL NOT BE HELD LIABLE FOR ANY ERRORS, OMISSIONS OR DISCREPANCIES THAT MAY OCCUR FROM THE USE OF THESE PLANS. FIELD VERIFICATION REQUIRED BY OTHERS FOR ACCURACY. THESE ARE NOT AND SHALL NOT BE USED FOR PERMIT AND/OR CONSTRUCTION PURPOSES. THESE ELECTRICAL PLANS ARE FOR FURNITURE REFERENCE ONLY AND SHALL NOT BE COPIED OR DISTRIBUTED WITHOUT A WRITTEN AUTHORIZATION FROM EMPIRE OFFICE.

ALL ELECTRICAL INFORMATION IS PROVIDED AS A COURTESY AND IT IS THE CLIENTS AND/OR THE CLIENTS REPRESENTATIVES (INCLUDING BUT NOT LIMITED TO GENERAL CONTRACTOR AND/OR ARCHITECT) RESPONSIBILITY TO FIELD VERIFY ALL DIMENSIONS / INFORMATION FOR ACCURACY. EMPIRE OFFICE SHALL BE HELD HAMRLESS OF ANY ERRORS, OMISSIONS OR DISCREPANCIES.

(NOT FOR ARCHITECTURAL PURPOSES)

PAGE NO: 5/6

## NUMC Coffee Shop Renovation STEELCASE

2201 Hempstead Turnpike

NY 11554

DWN BY: GG	REV	DWN	DATE
CHK BY: Dell			
DATE: 23.05.2019			
SCALE: -			
PRJ: NO: 000000			
APPROVED BY:			

www.empireoffice.com

# empire office

Tampa, FL  
5112 W. Linebaugh Ave  
Tampa, FL 33624  
813.418.3300  
Lic No: IB26001451

Orlando, FL  
110 Hillcrest St  
Orlando, FL 32801  
407.525.2400  
Lic No: IB26001451

Hollywood, FL  
2 Oakwood Blvd  
Suite 140  
Hollywood, FL 33020  
954.707.6200  
Lic No: IB26001451

HEADQUARTERS  
New York, NY  
105 Madison Avenue  
New York, NY 10016  
212.607.5500

# ISOMETRIC VIEW



C:\Users\deli\Documents\EMPIRE\NUMC\Coffee Shop Renovation\NUMC\_Coffee shop\_05-30-19.cmdrw

EMPIRE OFFICE SHALL NOT BE HELD LIABLE FOR ANY ERRORS, OMISSIONS OR DISCREPANCIES THAT MAY OCCUR FROM THE USE OF THESE PLANS. FIELD VERIFICATION REQUIRED BY OTHERS FOR ACCURACY. THESE ARE NOT AND SHALL NOT BE USED FOR PERMIT AND/OR CONSTRUCTION PURPOSES. THESE ELECTRICAL PLANS ARE FOR FURNITURE REFERENCE ONLY AND SHALL NOT BE COPIED OR DISTRIBUTED WITHOUT A WRITTEN AUTHORIZATION FROM EMPIRE OFFICE.

ALL ELECTRICAL INFORMATION IS PROVIDED AS A COURTESY AND IT IS THE CLIENTS AND/OR THE CLIENTS REPRESENTATIVES (INCLUDING BUT NOT LIMITED TO GENERAL CONTRACTOR AND/OR ARCHITECT) RESPONSIBILITY TO FIELD VERIFY ALL DIMENSIONS / INFORMATION FOR ACCURACY. EMPIRE OFFICE SHALL BE HELD HAMRLESS OF ANY ERRORS, OMISSIONS OR DISCREPANCIES.

(NOT FOR ARCHITECTURAL PURPOSES)

PAGE NO: 6/6

## NUMC Coffee Shop Renovation STEELCASE

2201 Hempstead Turnpike

NY 11554

REV	DWN	DATE
DWN BY:	GG	
CHK BY:	Dell	
DATE:	23.05.2019	
SCALE:	-	
PRJ/T NO:	000000	
APPROVED BY:		

www.empireoffice.com

**empire office**

**Tampa, FL**  
5112 W. Linebaugh Ave  
Tampa, FL 33624  
813.418.3300  
Lic No: IB26001451

**Orlando, FL**  
110 Hillcrest St  
Orlando, FL 32801  
407.626.2400  
Lic No: IB26001451

**Hollywood, FL**  
2 Oakwood Blvd  
Suite 140  
Hollywood, FL 33020  
954.707.6200  
Lic No: IB26001451

**HEADQUARTERS**  
New York, NY  
105 Madison Avenue  
New York, NY 10016  
212.607.5500